
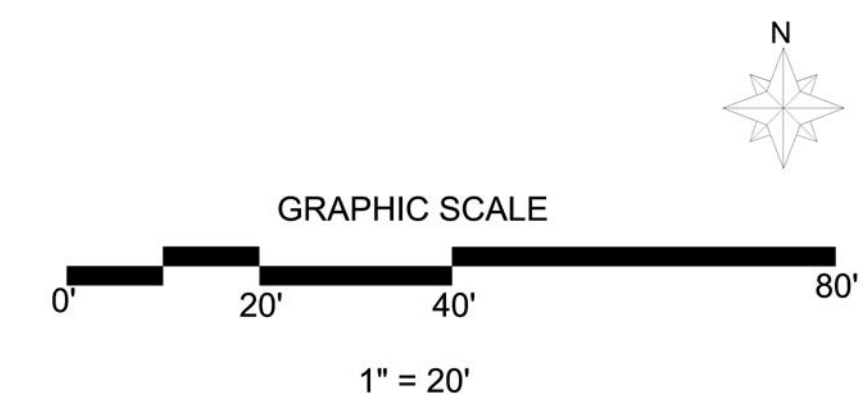


Lighting Legend		
Symbol	Manufacturer/Model #	Qty
T	Low Voltage Lighting Timer, by FX, Mod. PotenzaX 600W	2
	Brass Bullet w/18" Lead, by Corona Mod # CL514-B-AB	63

Note: Existing Palms Will Have the Light Fixtures 15' Above Ground.

General Lighting Notes:

1. This Plan is intended for Landscape Lighting Purposes only. All Lighting Fixtures and Transformers shall be Installed per Manufactures Specifications. It is the Contractors Responsibility to Maintain Compliance with local Building Safety Codes and Ordinances.
2. Fixtures are Shown in Approximate Location. The Contractor Show Field Verify the Actual Placement of Each Fixture Upon Completion of Landscape Installation.
3. All Path Lighths are to be Installed at a Minimum of 12 Inches from any Sidewalk or Vertical Structure.
4. All Low-Voltage Direct Burial Wire to be Installed \geq 6" Below Finish Grade per Electrical Code.
5. In Order to Minimize Future Disturbance, all Wires Runs Shall be Installed Paralel and Adjacent to Hard Surfaces Such as Sidewalks, Driveway and Walls.
6. The Contarctor Shall be Responsible for Installing Sleeves Under all Hardscape Surfaces Using a Minimum 1 Inch PVC Pipe.
7. All Underground Splices Shall be UL-486 Rated and Installed in Underground J-Boxes With Water Tight Connections Leaving 12 Inches of Excess Wire Slack.
8. All Exterior 120 - Volt Electrical Outlets Shall be GFI Protected as per National Electrical Code.
9. All Transformers Plugged into an Outdoor Recptable Shall Have an "In Use" Cover.
10. All Plug-In Transformers Shall Have a Drip Loop in the Power Code.
11. All Exposed Conduit's Shall be Painted to Match Surroundings.
12. The Installing Contractor Shall be Responsible for Adjusting the Fixtures at Night to Help Elimate Glare and to Ensure Optimum Lighting Effect.
13. Contractor to Verify a Minimum of 10 Volts at the Last Fixture for Optimal Operation.
14. Contractor to Center Feed the System When at all Possible and Verify all Wire Connections are at the Fixtures.
15. All Wire Connections at Fixtures Shall be Made Using Water Tight Connections.



Lighting Plan

Sheet Title

Designed by

Created by

Checked by

LM



**Indian Palms
Country Club
Enhancement East & West**

4/14/2023
Date

1"=20'
Scale

File Number

Page 1